



National Power Corporation

SUPPLEMENTAL/BID BULLETIN NO. 1 to the Bid Documents for the:

**LEASE OF 2.0 MW MODULAR DIESEL GENSETS FOR EL NIDO DPP UNDER PR NO. S1-
END22-003 / REF NO. PB220725-NA (PB2)**

15 AUGUST 2022

All prospective bidders and authorized copy holders of the Bid Documents of the above mentioned project are hereby advised of the **PLANT AND EQUIPMENT LAYOUT**, to wit:

Please refer to the attached PLANT AND EQUIPMENT LAYOUT.

All other terms and conditions shall remain the same.


For the information and guidance of all authorized copy holders of the Bid Documents and prospective bidders.

For the Bids and Awards Committee:


RENE B. BARRUELA

Vice President, Corporate Affairs Group and
Chairman, Bids and Awards Committee



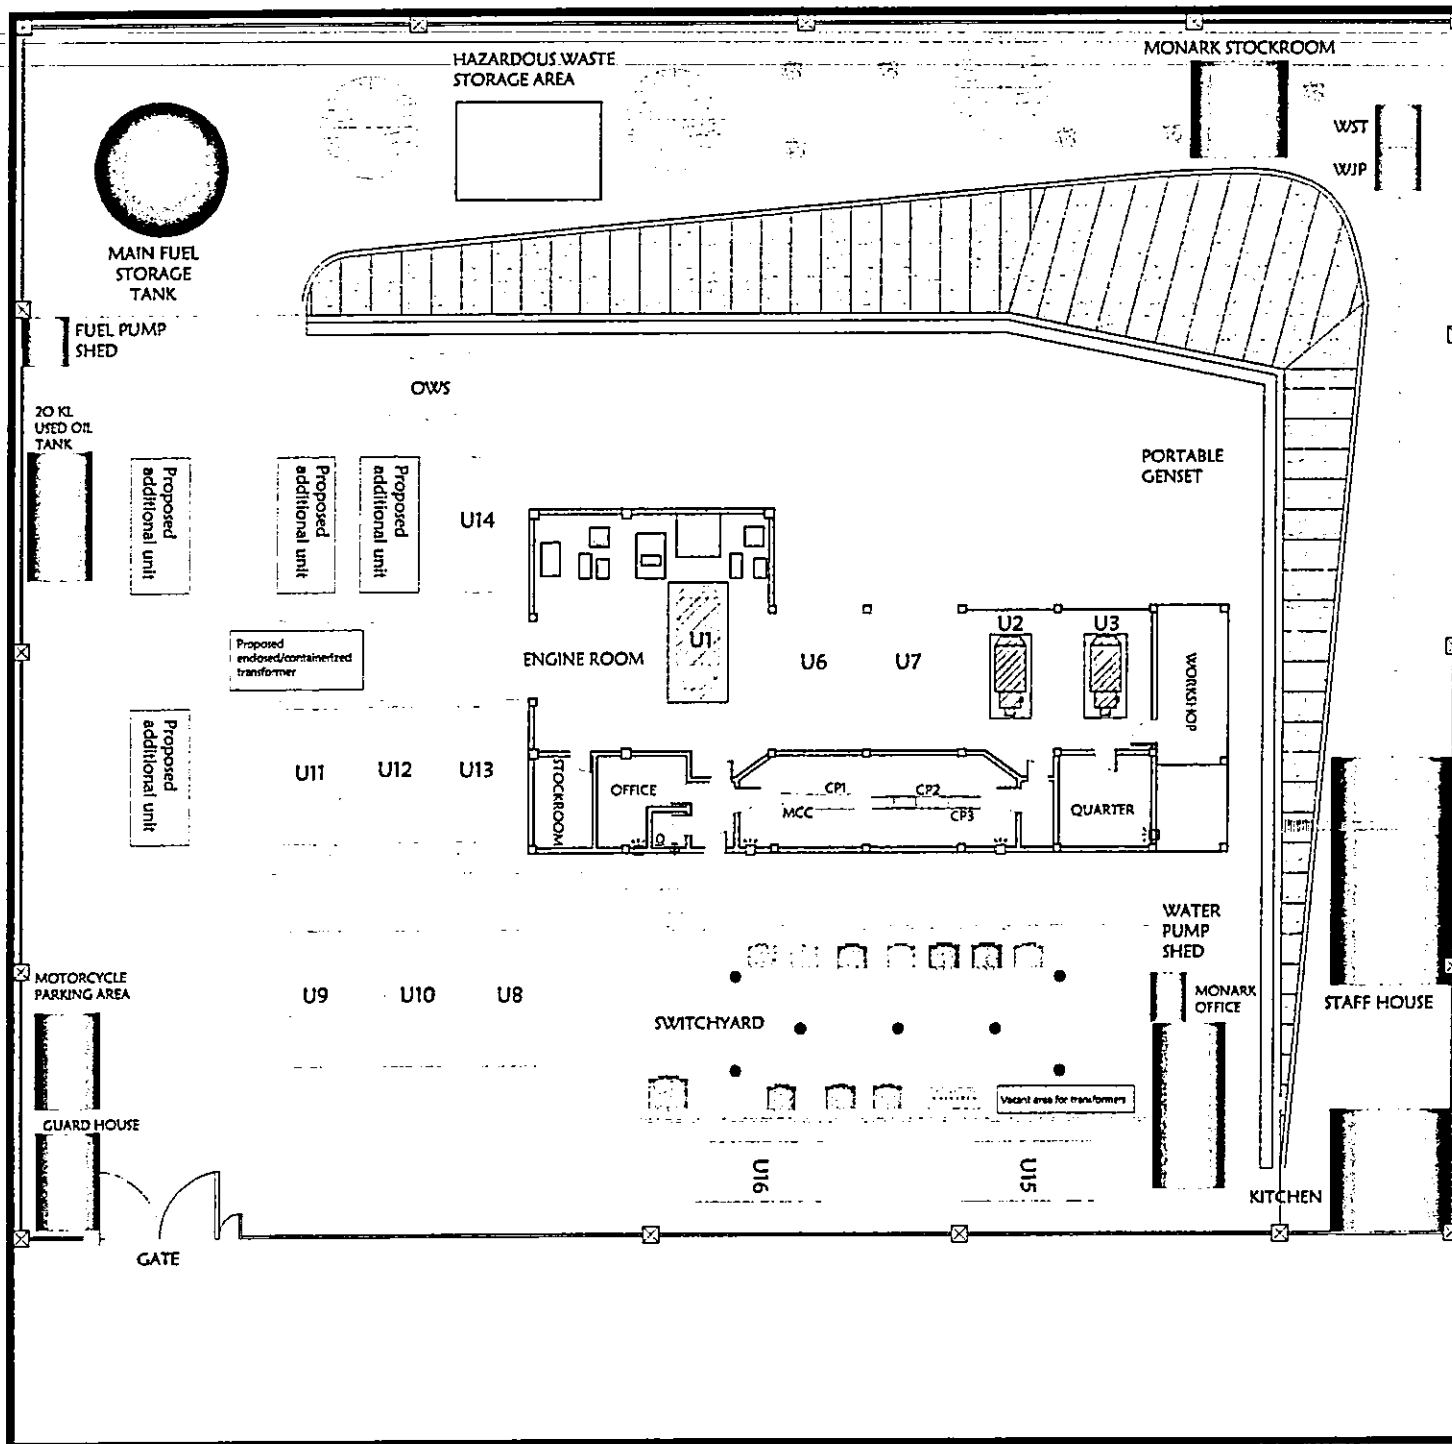

NPC UNITS

- U1 - 500 KW DIESEL ENGINE (MAN-CXZ)
- U2 - 600 KW DIESEL ENGINE (TIDEPOWER)
- U3 - 600 KW DIESEL ENGINE (TIDEPOWER)
- U6 - 600 KW DIESEL ENGINE (TPI)
- U7 - 600 KW DIESEL ENGINE (TPI)

RENTAL UNITS

- U8 - 910 KW DIESEL ENGINE (MONARK)
- U9 - 910 KW DIESEL ENGINE (MONARK)
- U10 - 910 KW DIESEL ENGINE (MONARK)
- U11 - 910 KW DIESEL ENGINE (MONARK)
- U12 - 910 KW DIESEL ENGINE (OMCPC)
- U13 - 455 KW DIESEL ENGINE (OMCPC)
- U14 - 910 KW DIESEL ENGINE (OMCPC)
- U15 - 910 KW DIESEL ENGINE (MONARK)
- U16 - 455 KW DIESEL ENGINE (MONARK)

OWS - OIL WATER SEPARATOR
WJP - WATER JET PUMP HOUSE
WST - WATER STORAGE TANK

NATIONAL POWER CORPORATION			
SMALL POWER UTILITIES GROUP LUZON OPERATIONS DEPARTMENT PALAWAN AREA OPERATIONS DIVISION			
DRAFTED	EJ O. GABUTERO SENIOR ENGINEER	PLANT LAYOUT	
RECOMMENDED	J.T. VALLEDOR PLANT HEAD	EL NIDO DIESEL POWER PLANT EL NIDO, PALAWAN, PHILIPPINES	
APPROVED	F. B. BARRIOS DIVISION MANAGER, POD	DATE: AUG 10, 2022	REVISION: 5
		DRAWING NUMBER: POD-EJN-001	SHEET 1 / 1